


DRAWN BY:	REV:	DATE:
PATF		DEC 10, 2008
CON:	SCALE:	
LL3-06	1" = 25'	

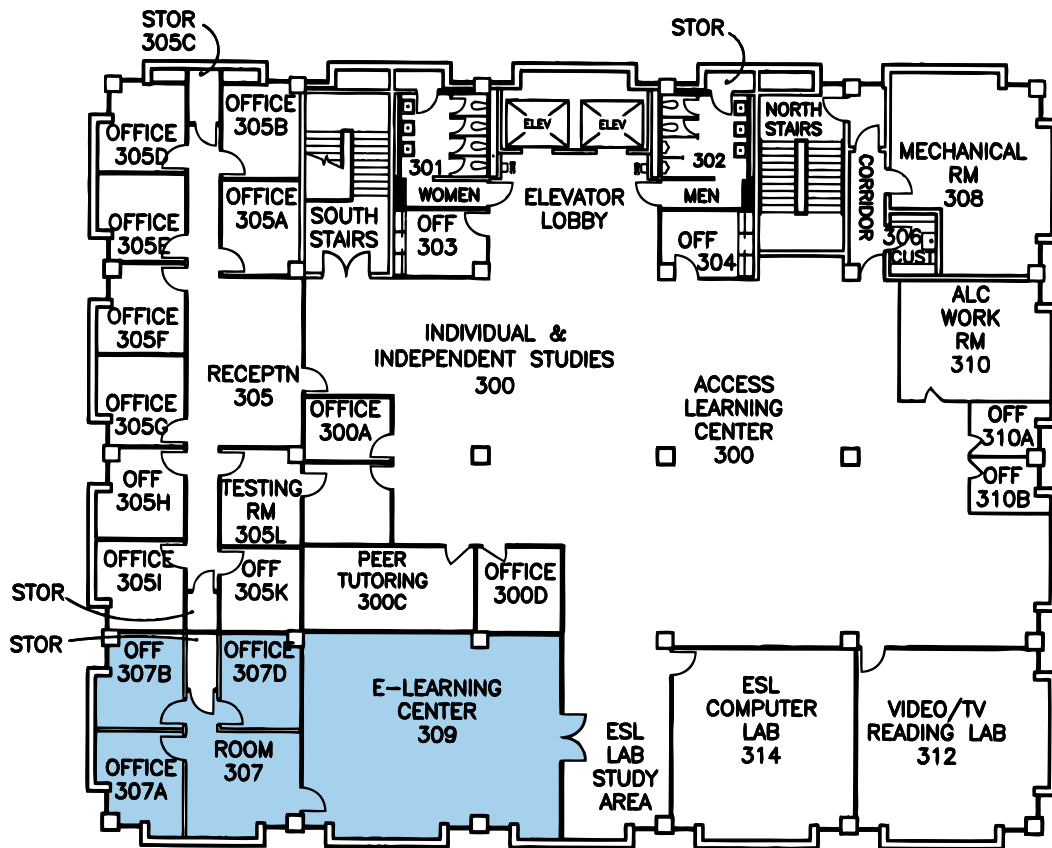

AMARILLO COLLEGE
WASHINGTON ST. CAMPUS

LYLNN LIBRARY
THIRD FLOOR PLAN